



FRONT VIEW

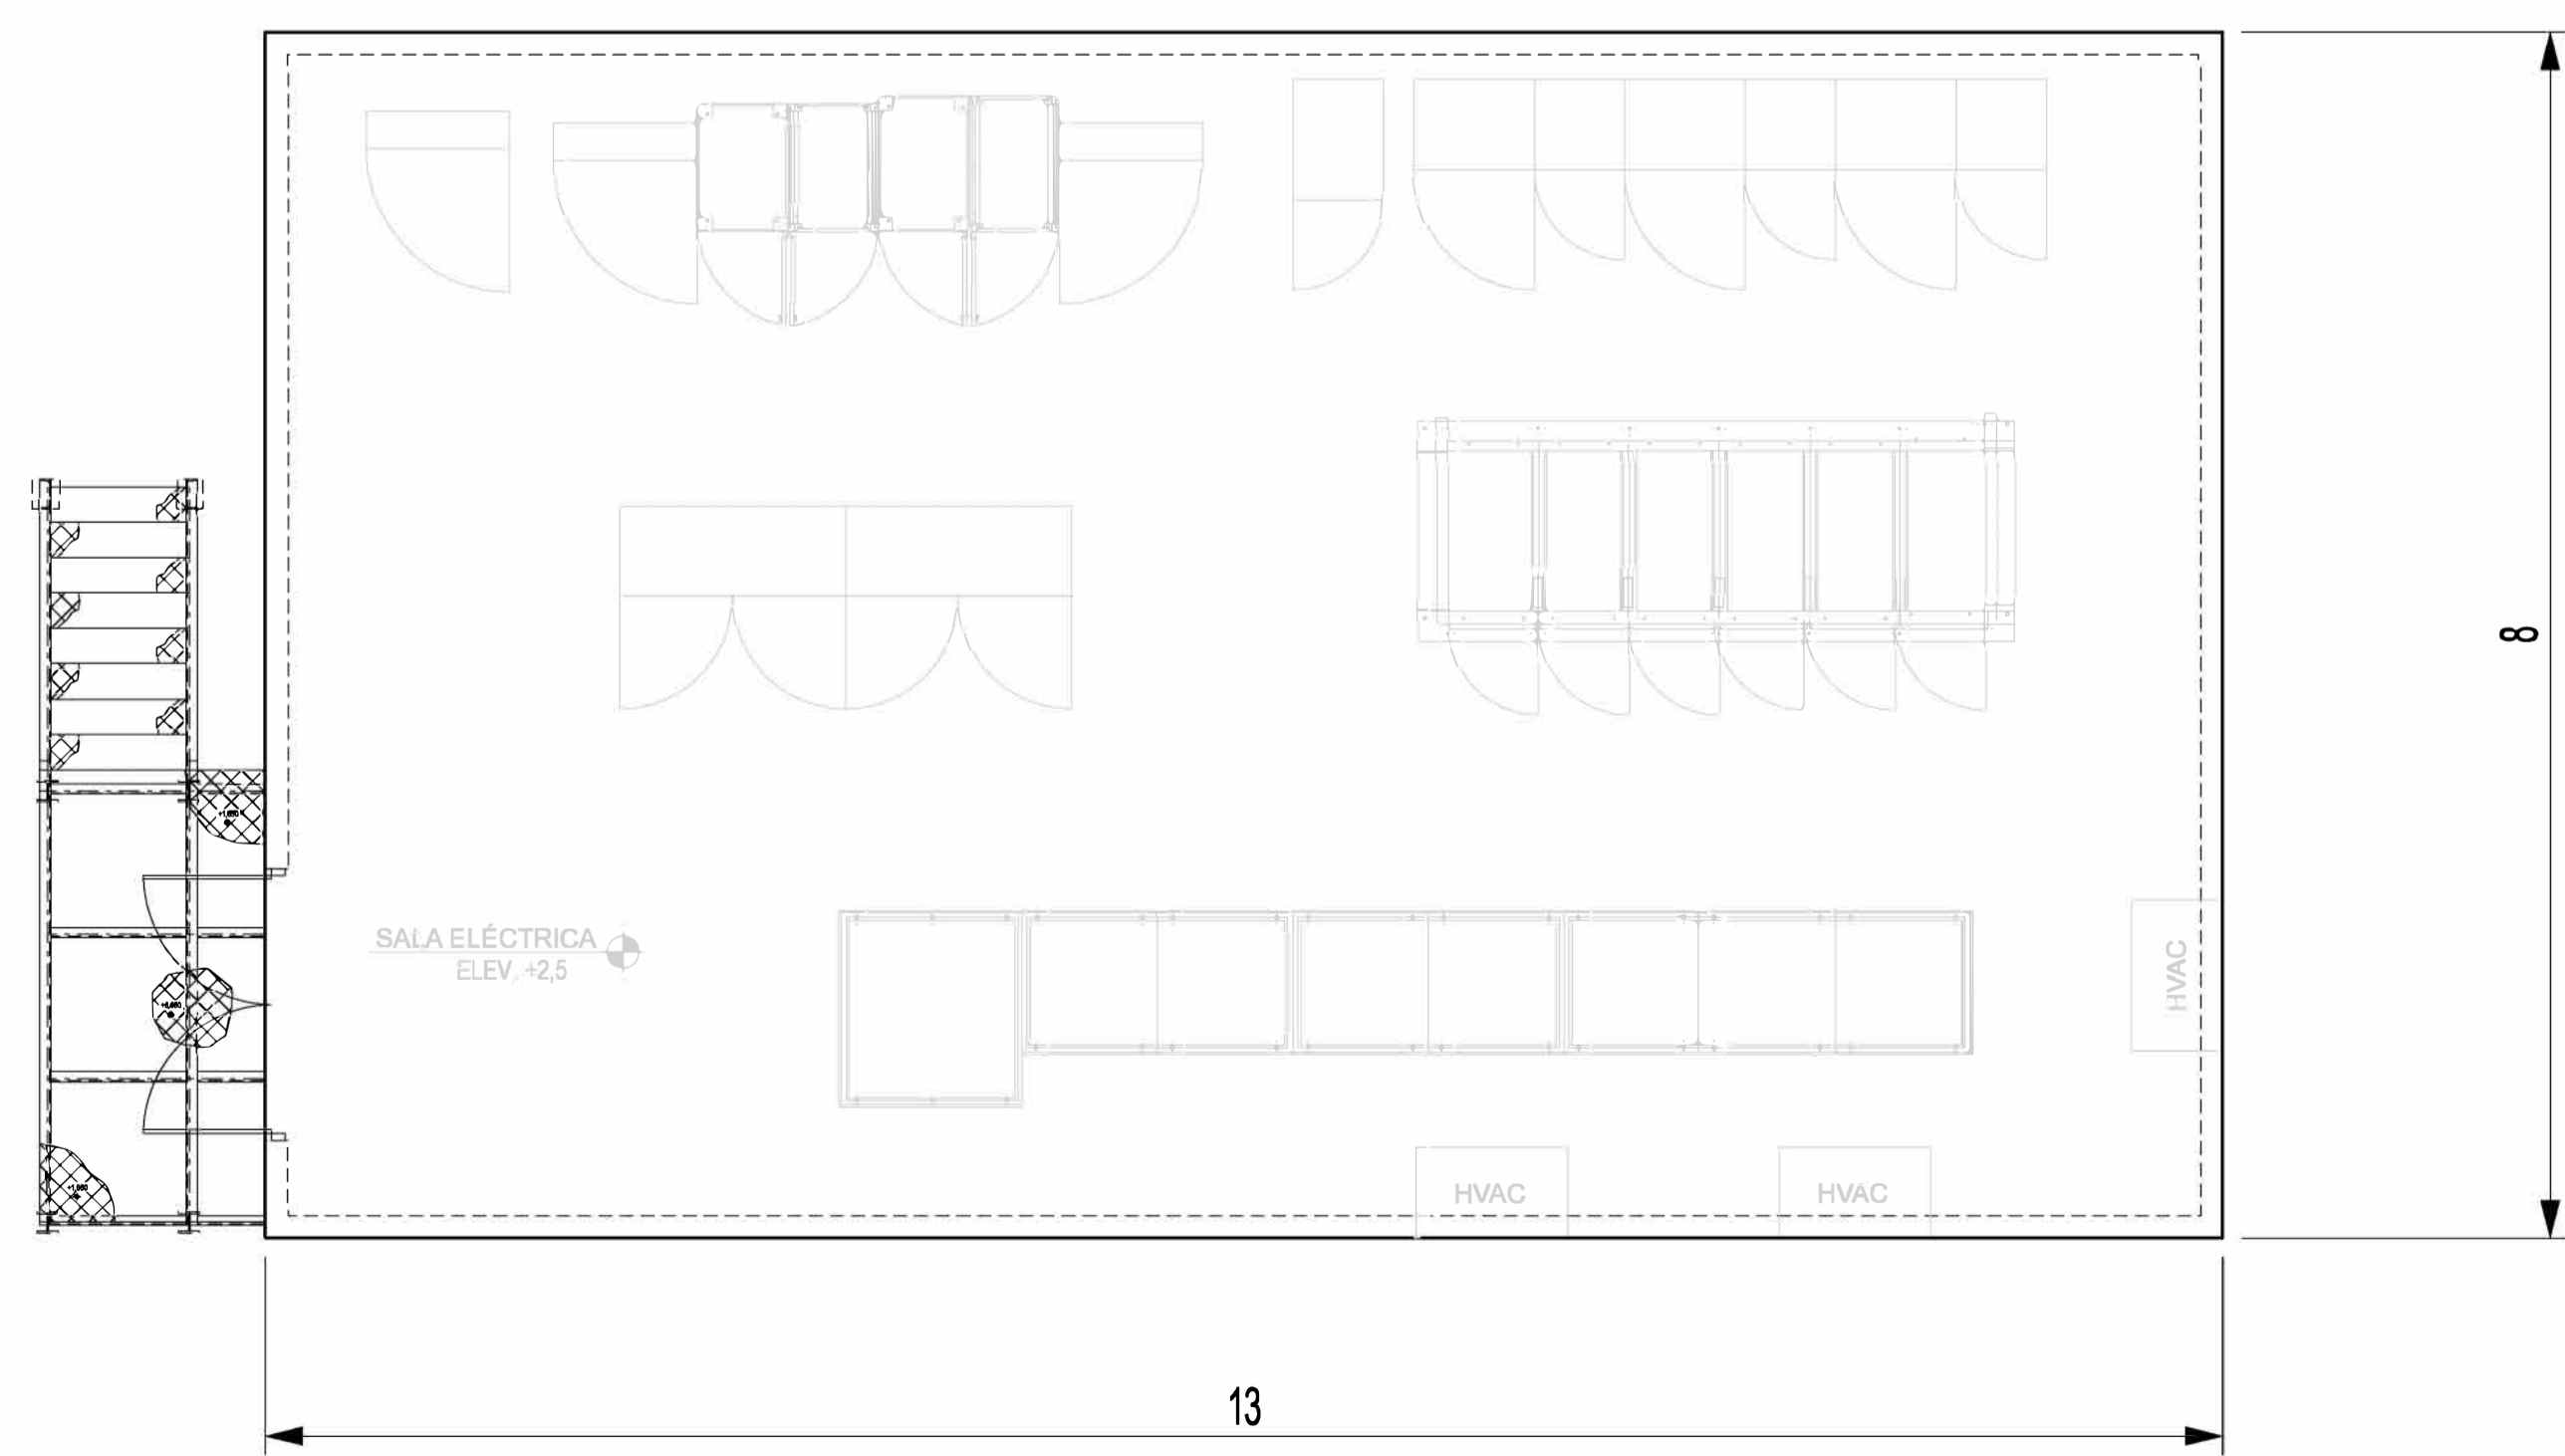

PLANT VIEW

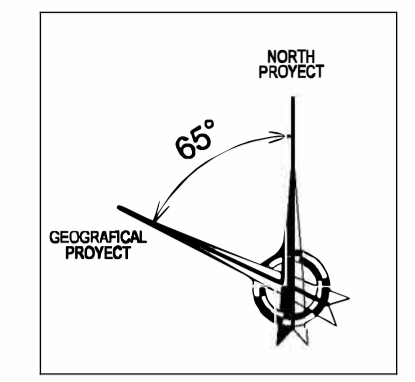

- NOTES:
- DIMENSIONS IN METERS.
  - COORDINATES IN METERS
  - DIMENSIONS TAKE PREFERENCE OVER THE DRAWING.
  - THE LAYOUT SHOWN IN THE DRAWING IS PRELIMINARY AND WILL BE SUBJECT TO REVISIONS

SCALE:					
FIRST ISSUE: 05/12/2023 Drawn: JOLA, JOLA, PASTOR, LUCAS Prep: JOLA, PASTOR, LUCAS Check: JOLA, PASTOR, LUCAS Approv: JOLA, PASTOR, LUCAS		Client: Iberdrola		H2 CROMARTY APPLICATION DRAWING INDICATIVE LAYOUT ELECTRICAL MV/LV BUILDING ELEVATION AND FLOOR PLAN H2CRO-19-YTG-DA-IBEEI-0109	
Contractor: JOLA, JOLA, PASTOR, LUCAS		Class: - Type: - Nº: -		Replaces: - Sheet: 1 Next: - Rev: 0 Scale: A1	